

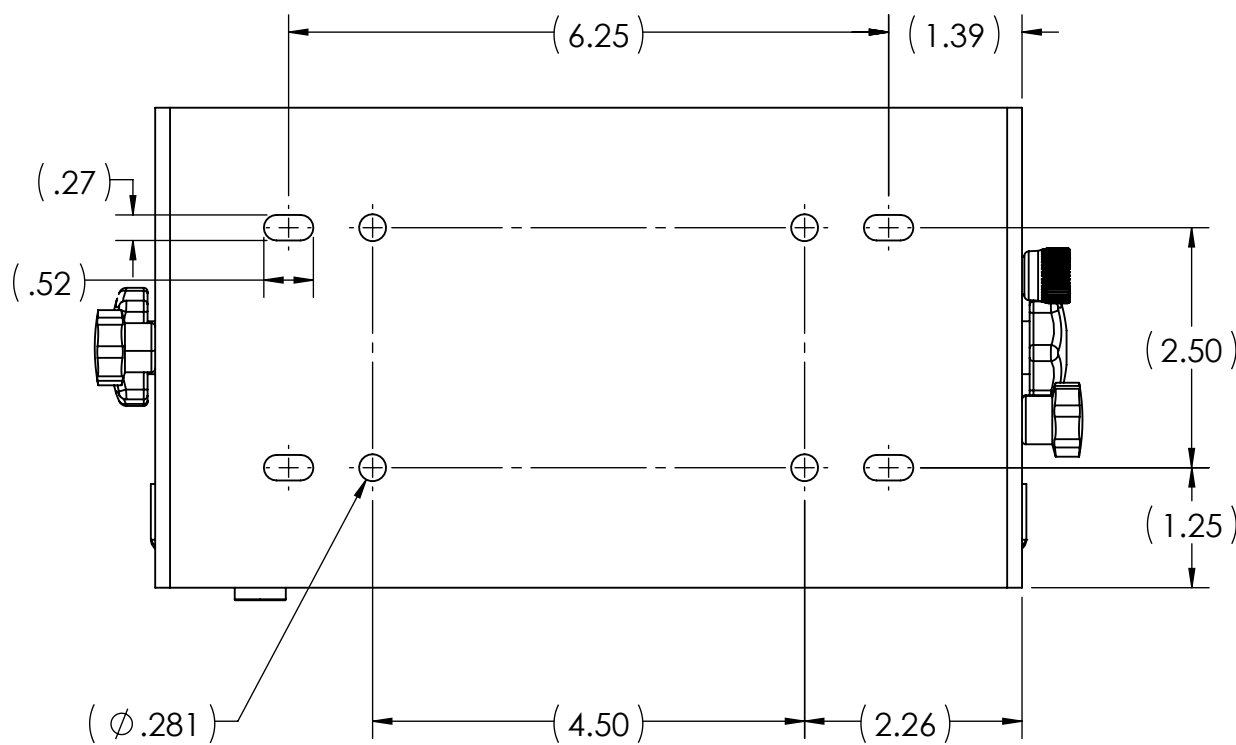
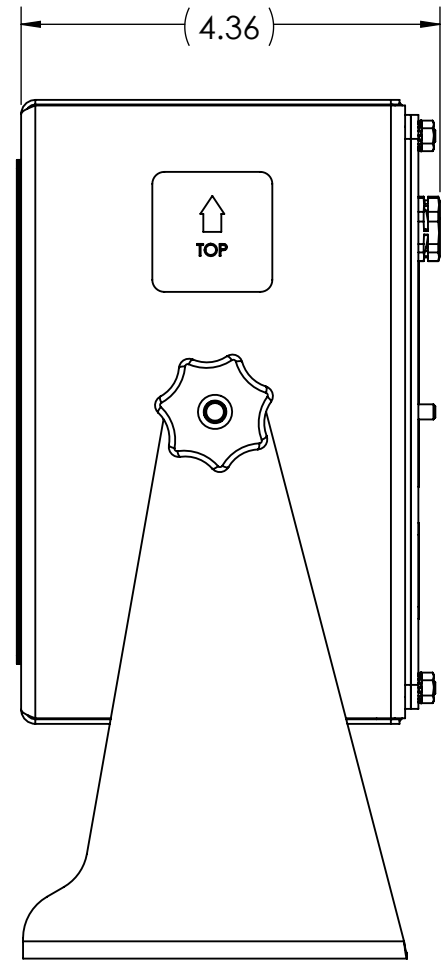
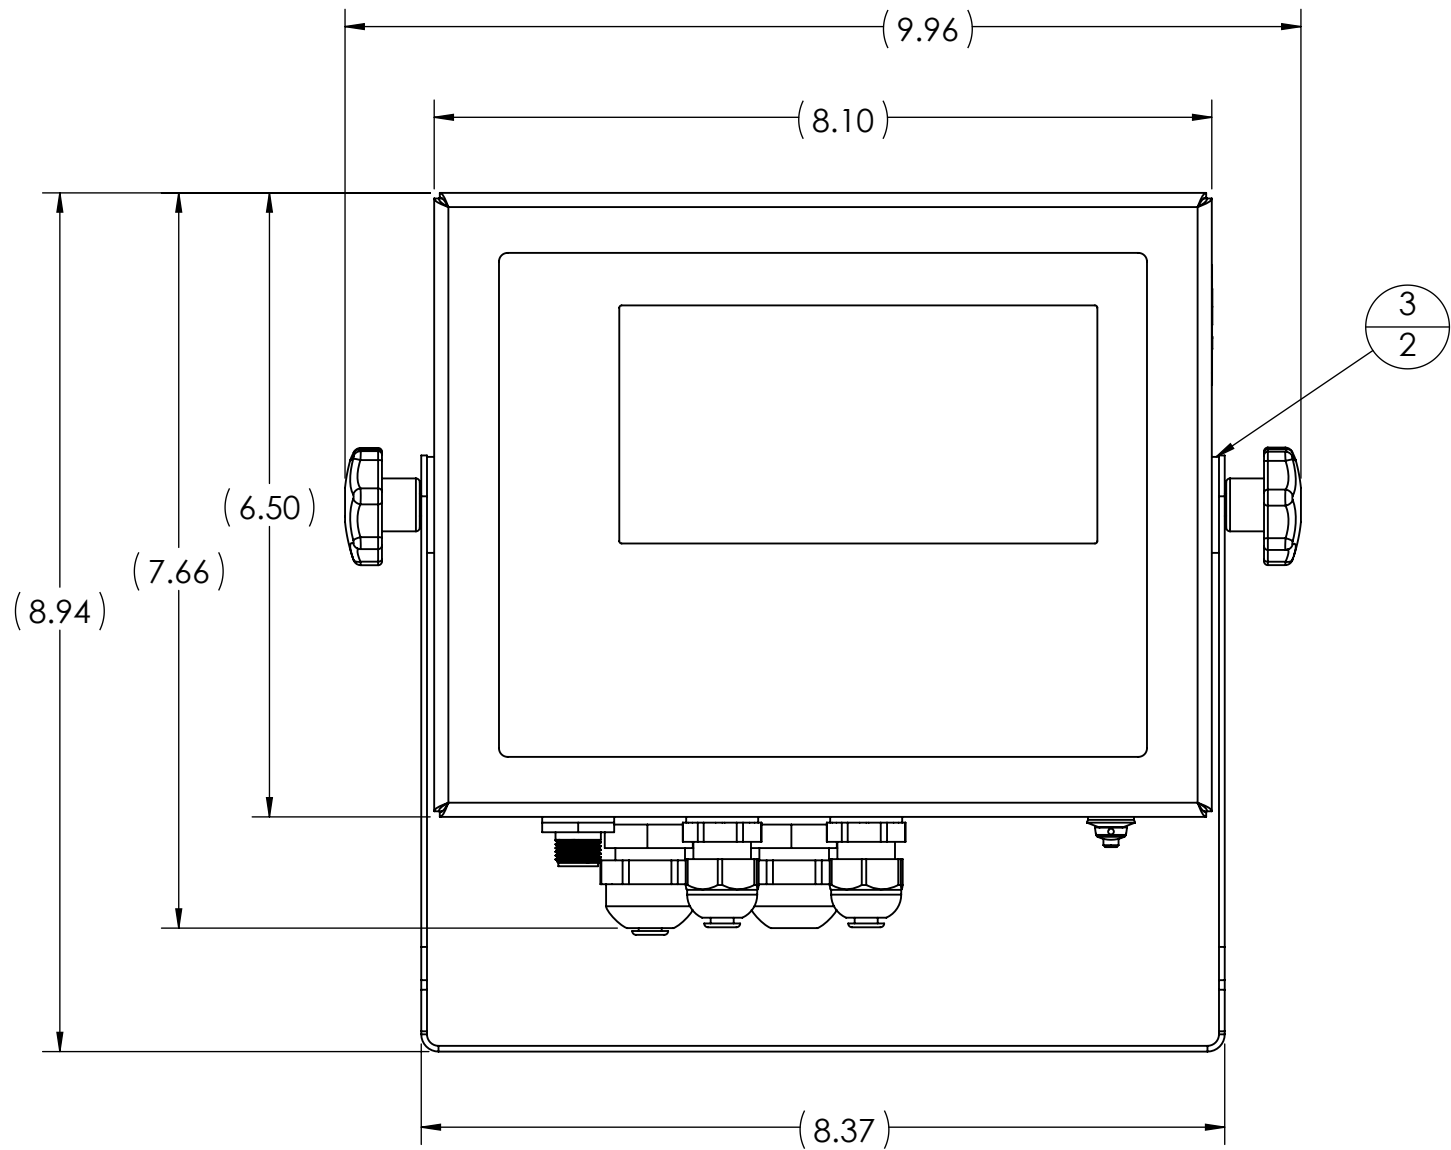
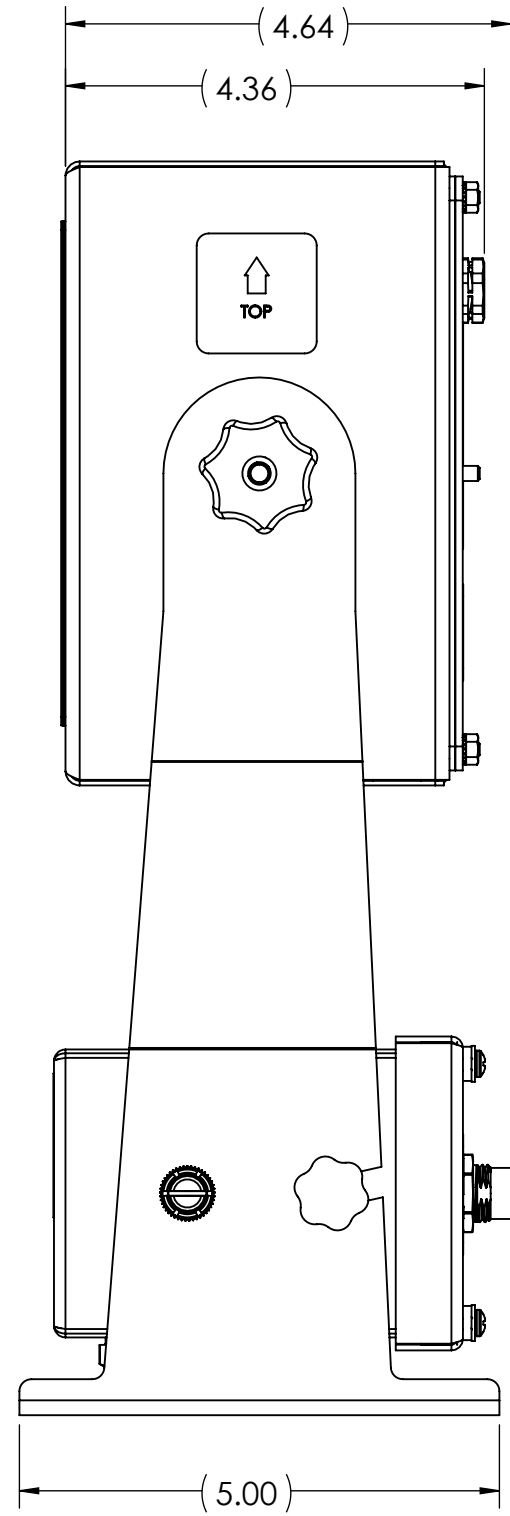




REVISION				
REV	ECO	DESCRIPTION	INIT	DATE

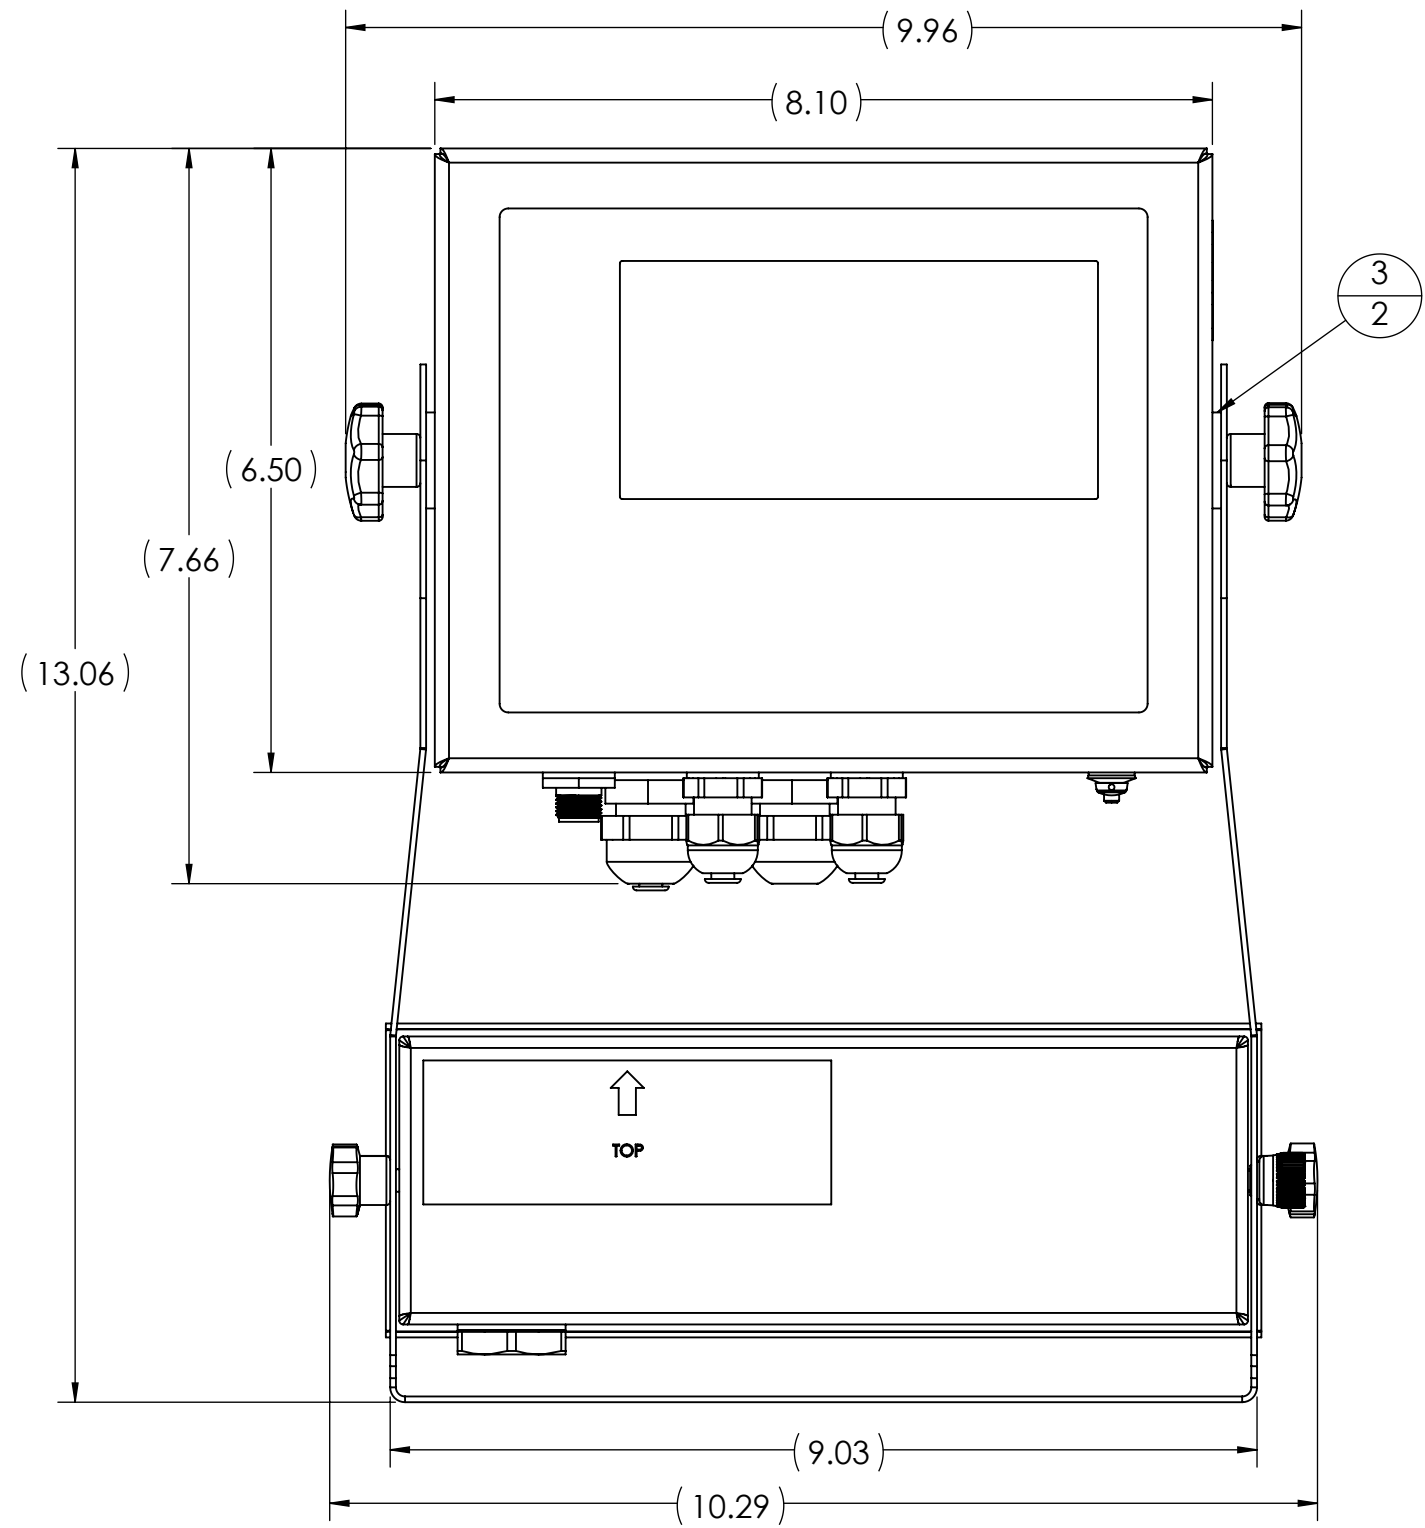

BATTERY OPTION LAYOUT VIEWS

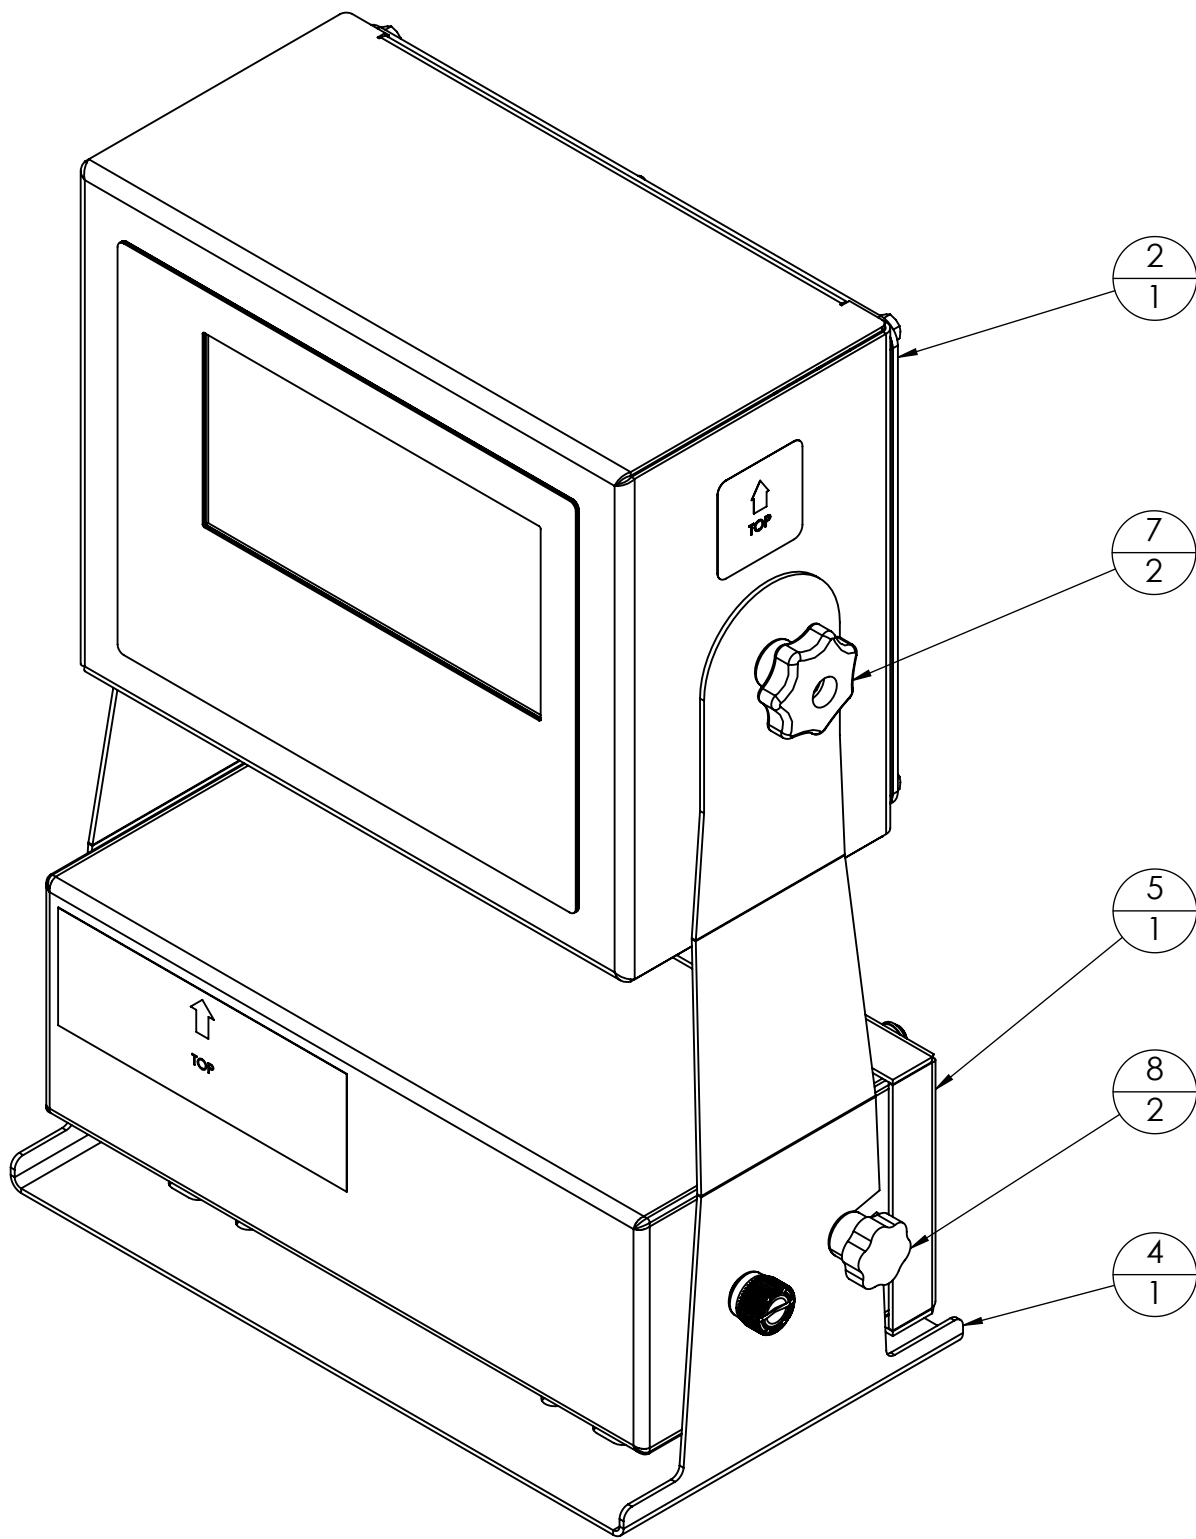

AC POWER LAYOUT VIEWS

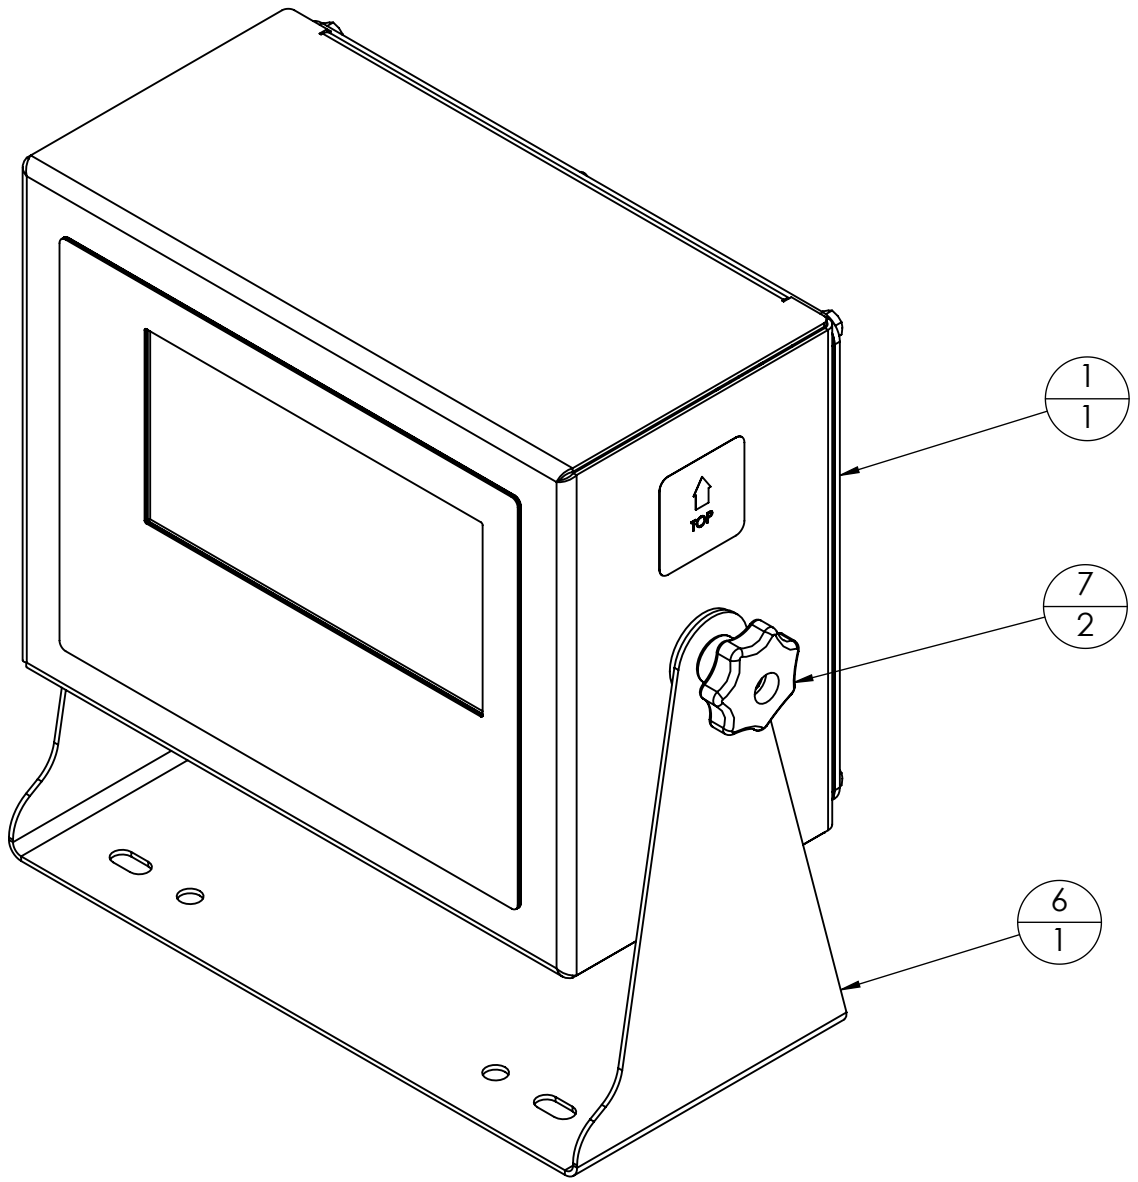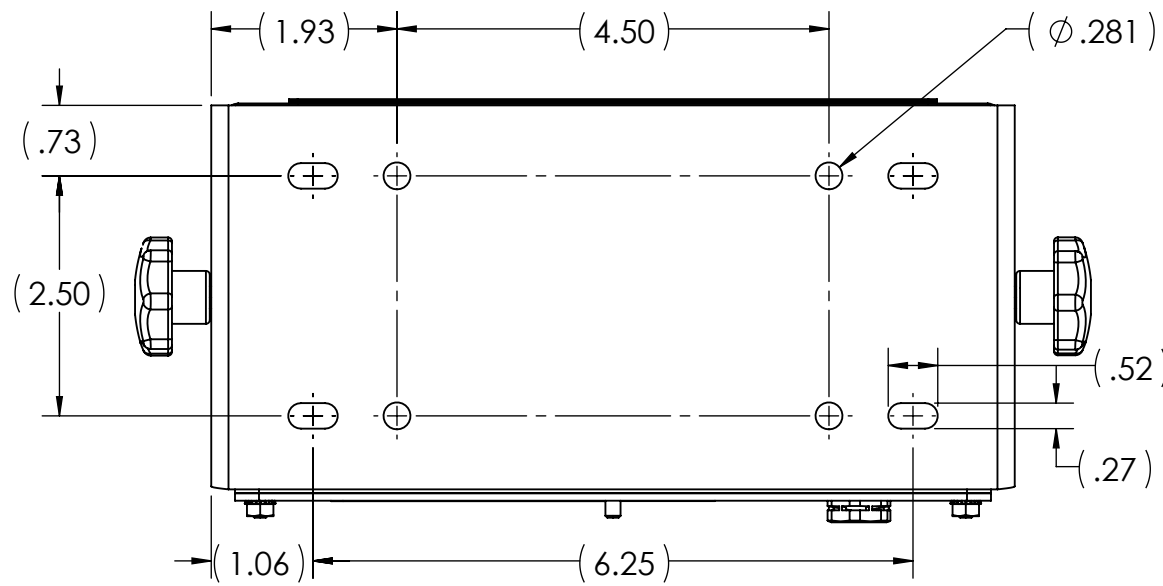

ITEM NO.	PART NUMBER	DESCRIPTION	185288 882IS BATTERY OPTION QTY.	185290 882IS AC POWER QTY.	185291 882IS PLUS BATTERY OPTION QTY.	185293 882IS PLUS AC POWER QTY.
1	180829	INDICATOR, 882IS LCD DISPLAY, INTRINSICALLY SAFE WEIGHT INDICATOR	1	1	-	-
2	177707	INDICATOR, 882IS PLUS LCD DISPLAY, INTRINSICALLY SAFE WEIGHT INDICATOR	-	-	1	1
3	103988	Washer,Nylon .515-.52	2	2	2	2
4	179678	TILT STAND,882IS BATTERY OPTION	1	-	1	-
5	180831	BATTERY OPTION,IS-6VDC	1	-	1	-
6	163751	Tilt Stand,880 Desktop	-	1	-	1
7	180825	KNOB,M6x1 THREADED THRU 32mm DIA 7-LOBE NYLON ZN-PLTD STEEL	2	2	2	2
8	180863	KNOB, M6x1x15mm STUD 6 LOBED 20mm DIA	2	-	2	-

NOTES:

1. ITEMS PER BOM TABLE MATRIX.

DESIGNED BY/DATE C.CHRISTIANSON 11/03/2017		DRAWN BY/DATE C.CHRISTIANSON 11/06/2017		PEER APPROVAL/DATE	
TREATMENT NONE		THIS DRAWING AND INFORMATION CONTAINED HEREIN IS AND REMAINS THE PROPERTY OF RICE LAKE WEIGHING SYSTEMS INC. - HEREINAFTER REFERRED TO AS RLWS. IT MAY BE USED ONLY FOR RLWS' PROPOSAL AND/OR ITS CUSTOMER'S ORDERS. IT SHALL NOT BE DISCLOSED OR COPIED WITHOUT RLWS SPECIFIC WRITTEN CONSENT AND SHALL BE IMMEDIATELY RETURNED UPON REQUEST.		UNLESS OTHERWISE SPECIFIED UNITS TO BE INCHES ALL THREADS TO BE CLASS 2 ALL DIMENSIONS APPLICABLE AFTER TREATMENT	
NUMBER OF CRANES: MINIMUM CRANE CAPACITY: ESTIMATED WEIGHT (POUNDS): 0.00		TOLERANCES DRAWING TOLERANCES UNLESS OTHERWISE SPECIFIED DO NOT SCALE SURFACE FINISH XXX: ±.01 .XXX: ±.005 ANGLE: ±1°		DESCRIPTION 882IS TOP LEVEL INDICATOR WITH STAND AND BATTERY OR AC POWER SUPPLY SCALE: 1:2 SHEET 1 OF 1 MATERIAL: SEE BOM THIRD ANGLE PROJECTION: PART: 882IS-TOPLEVEL REV: P1	

RICE LAKE
WEIGHING SYSTEMS